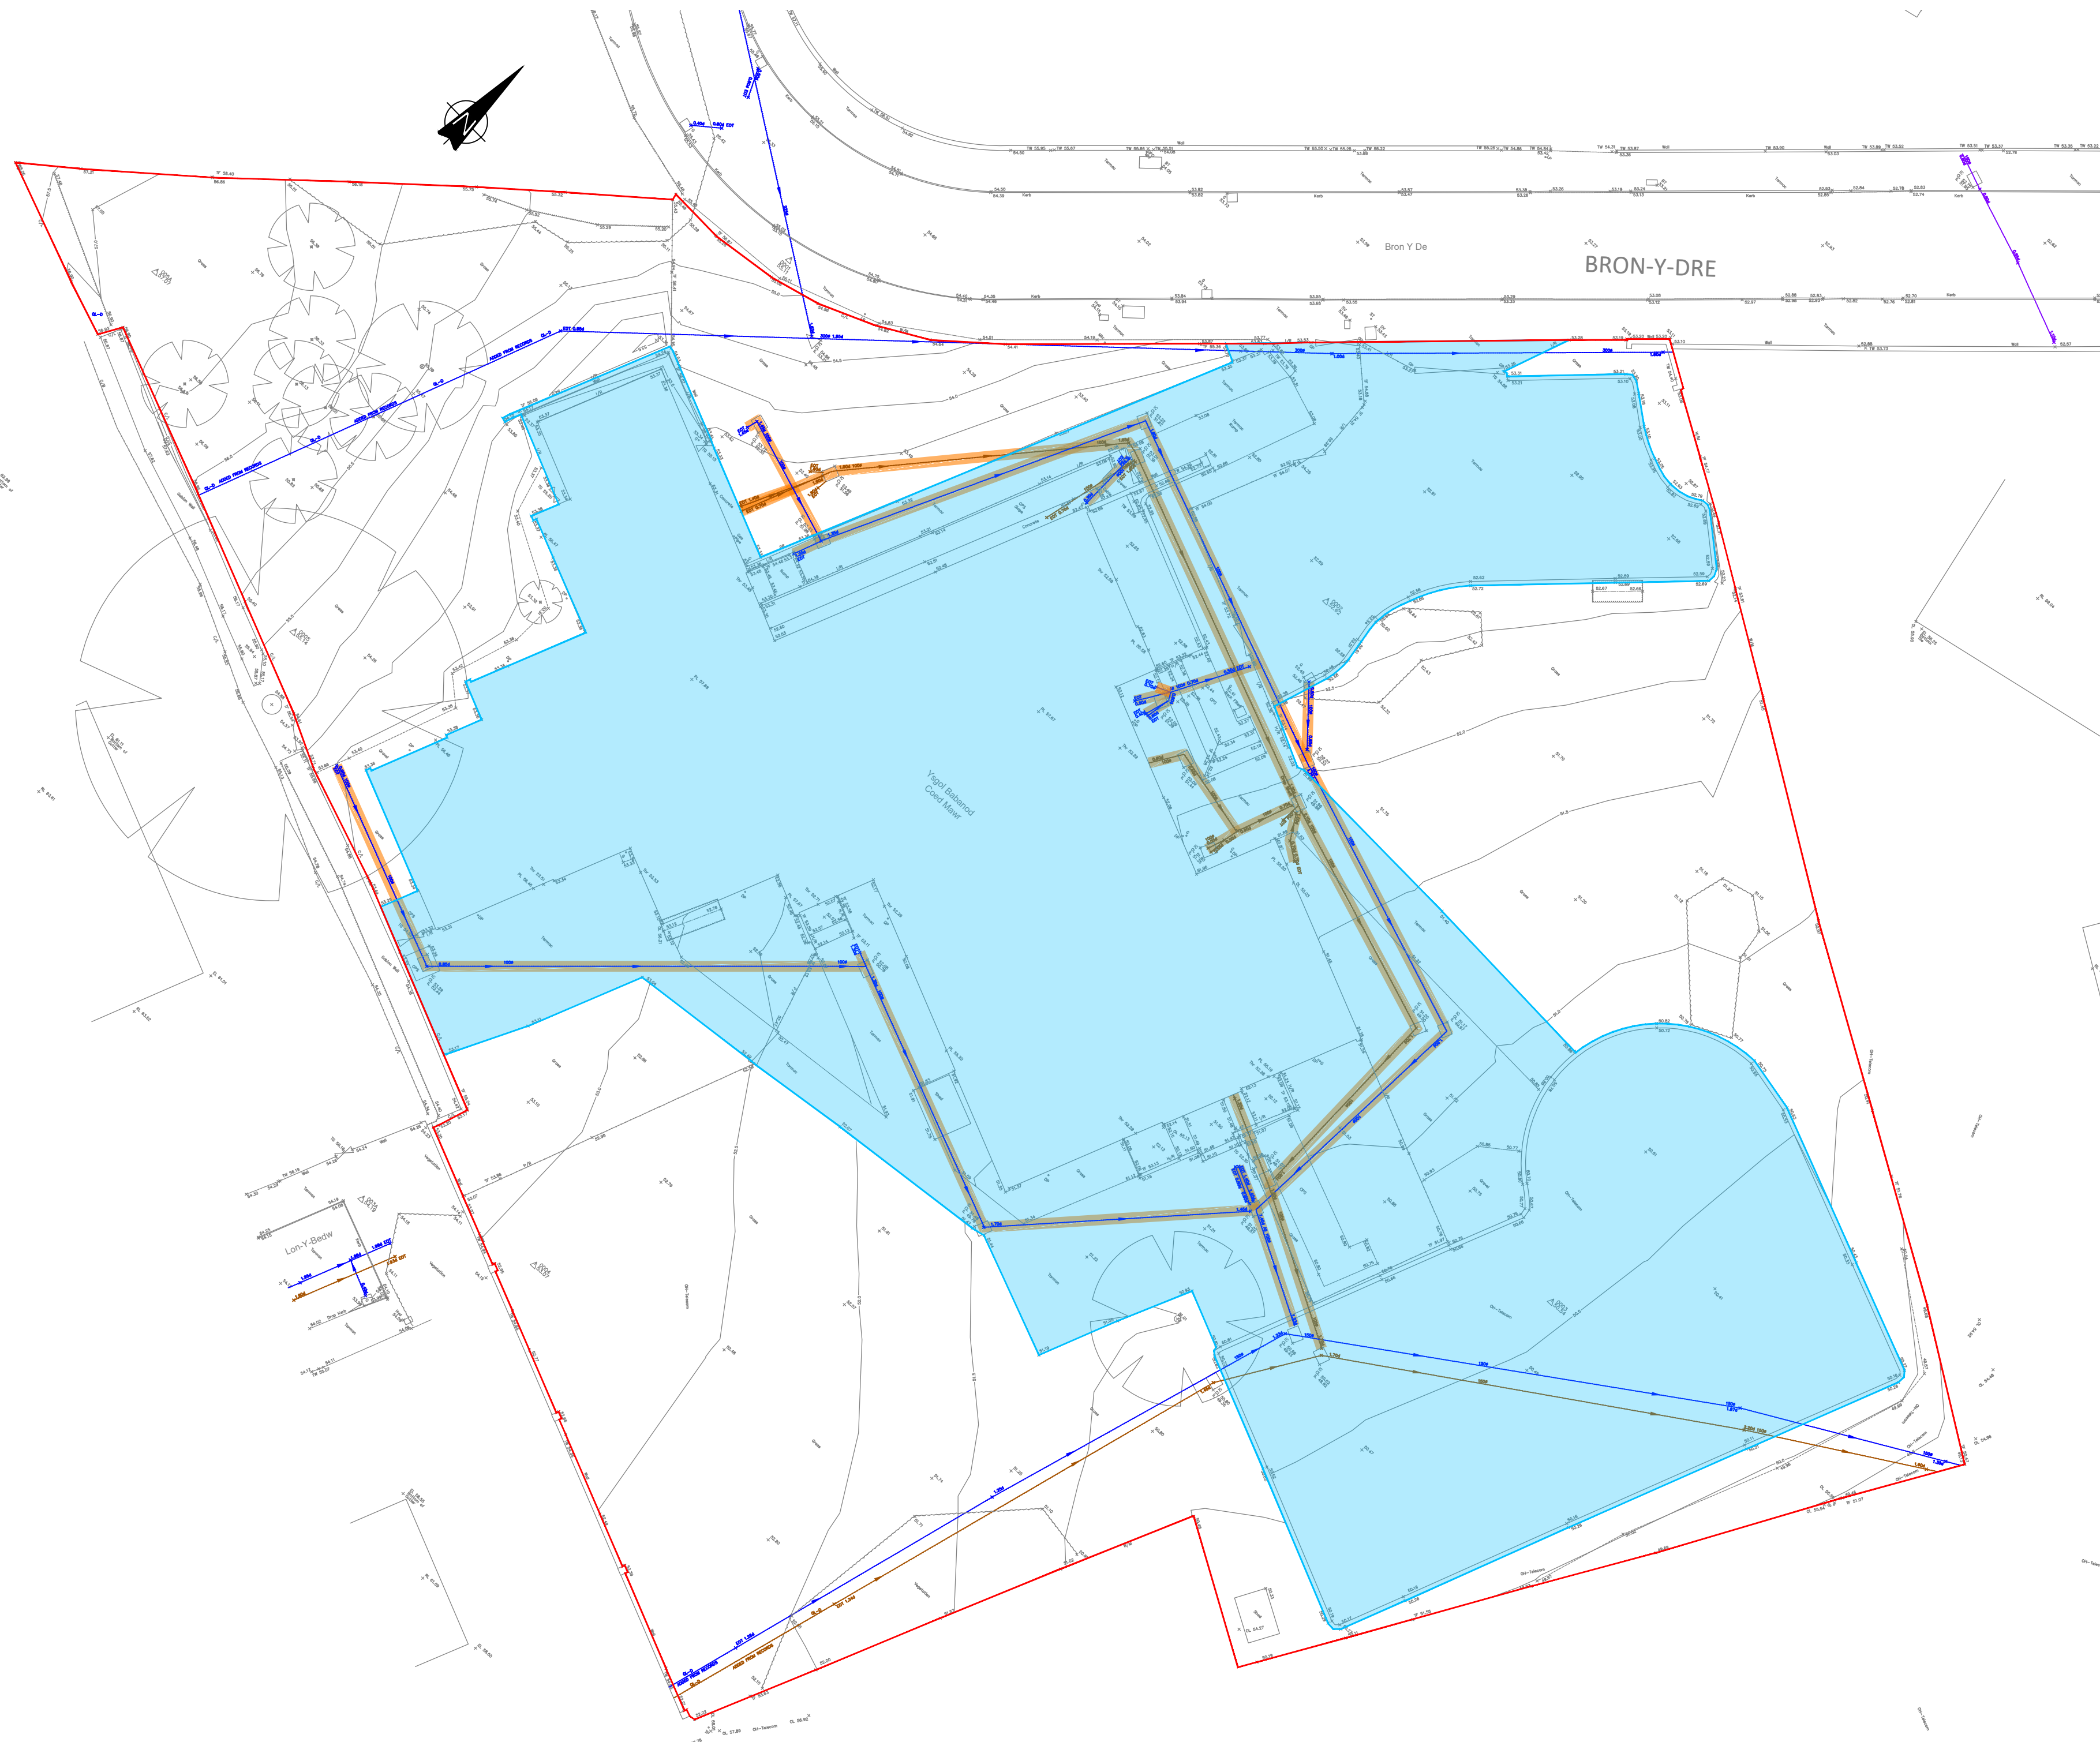
 
 
 

 
 




NOTES

- DO NOT SCALE FROM THIS DRAWING, WORK FROM FIGURED DIMENSIONS ONLY. ALL DIMENSIONS ARE IN METRES AND ALL LEVELS ARE IN METRES ABOVE ORDNANCE DATUM UNLESS NOTED OTHERWISE.
- THIS DRAWING IS TO BE READ IN CONJUNCTION WITH ALL RELEVANT ARCHITECTS, ENGINEERS AND SPECIALIST DRAWINGS AND SPECIFICATIONS.



KEY

-  EXISTING SURFACE WATER DRAINAGE TO BE RETAINED
-  EXISTING FOUL WATER DRAINAGE TO BE RETAINED
-  EXISTING SURFACE WATER DRAINAGE TO BE GRUBBED OUT
-  EXISTING FOUL WATER DRAINAGE TO BE GRUBBED OUT
-  EXISTING IMPERMEABLE AREA - 2128m² (0.213Ha)
-  SITE BOUNDARY - 4025m² (0.403Ha)

P02	SAB PRE-APP SUBMISSION	NWO	-	-	01/03/24		
P01	ISSUED FOR COMMENT	NWO	-	-	28/02/24		
REV	MODIFICATIONS	BY	RE	AP	DATE		
PURPOSE OF ISSUE					STATUS		
DRAFT					SO		
CLIENT:							
							
PROJECT:							
FORMER YSGOL BABANOD COED MAWR BRON-Y-DRE BANGOR							
TITLE:							
EXISTING FOUL AND SURFACE WATER DRAINAGE LAYOUT							
DESIGNED BY	DRAWN BY	REVIEWED BY	AUTHORISED BY				
NWO	NWO						
DATE	SCALE @ A2	JOB REF:	REVISION				
23/02/24	1:200	5318	P02				
DRAWING NUMBER							
5318-CAU-XX-XX-SK-C-0101							
							

Registered Office: Intec, Parc Menair, Bangor, Gwynedd, LL57 4FG Company Registered No: 06716319

© COPYRIGHT CAULMERT LIMITED - NOT TO BE COPIED OR REPRODUCED IN ANY WAY OR FOR ANY PURPOSE WITHOUT PRIOR WRITTEN CONSENT FROM CAULMERT LIMITED